




Pierce/Frontline Communications Freightliner Command Unit
Middlesex County OEM
Job #91813

FEATURES & SPECIFICATIONS

- Freightliner M2-106 Chassis
- Cummins ISL 350 hp Engine
- Allison EVS4000P Automatic Transmission
- 40' overall length; 30'10" Box
- Two (2) slide-out sections
- Five (5) workstations and a 10-person conference table
- EPS 20kw Diesel Generator
- Delivered in April 2019



FIRE & SAFETY SERVICES, LTD.
South Plainfield, NJ
web: www.f-ss.com · phone: 800-400-8017

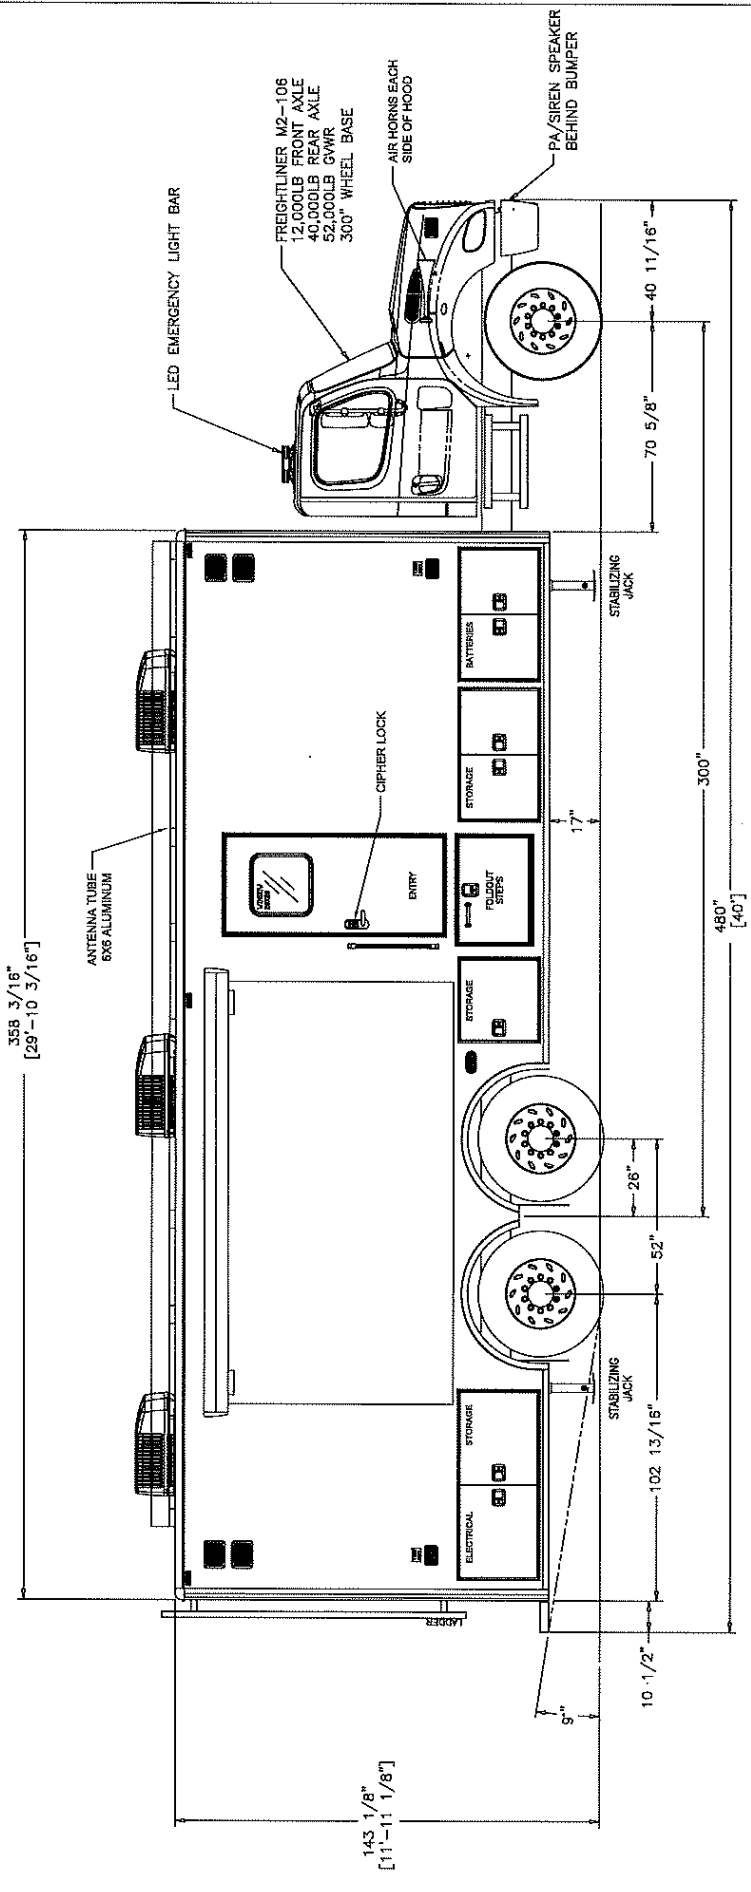

<p>FRONTLINE COMMUNICATIONS 12780-4465 Street North Plymouth, MN 55442 Phone (727) 573-9400 www.frontlinecomm.com</p>		<p>Middlesex County Emergency Management MCV - C-40X-2 - M2-106</p>	
<p>THIS DRAWING IS THE PROPERTY OF FRONTLINE COMMUNICATIONS. IT IS CONFIDENTIAL AND ALL RIGHTS ARE RESERVED. IT SHALL NOT BE REPRODUCED OR TRANSMITTED IN ANY FORM OR BY ANY MEANS, ELECTRONIC OR MECHANICAL, INCLUDING PHOTOCOPYING, RECORDING, OR BY ANY INFORMATION STORAGE AND RETRIEVAL SYSTEM, WITHOUT THE WRITTEN PERMISSION OF FRONTLINE COMMUNICATIONS. ANY UNAUTHORIZED USE OR REPRODUCTION OF THIS DRAWING IS STRICTLY PROHIBITED AND WILL BE PROSECUTED TO THE FULL EXTENT OF THE LAW.</p>		<p>DATE: 4-17-18 NOT TO SCALE</p>	
<p>PRELIMINARY USE ONLY THIS DRAWING IS FOR REPRESENTATION ONLY. DETAILED ENGINEERING DRAWINGS WILL BE CREATED FOR MANUFACTURING PURPOSES AND TO ACCOMMODATE MANUFACTURING REQUIREMENTS AND CUSTOMER SPECIFICATIONS.</p>		<p>SIZE: B DWG NO.: 050007</p>	
<p>DRAWN: J.Chitiss</p>	<p>SHEET: 1 OF 5</p>	<p>REV: -</p>	<p>REV: -</p>

CURB SIDE EXTERIOR ELEVATION